


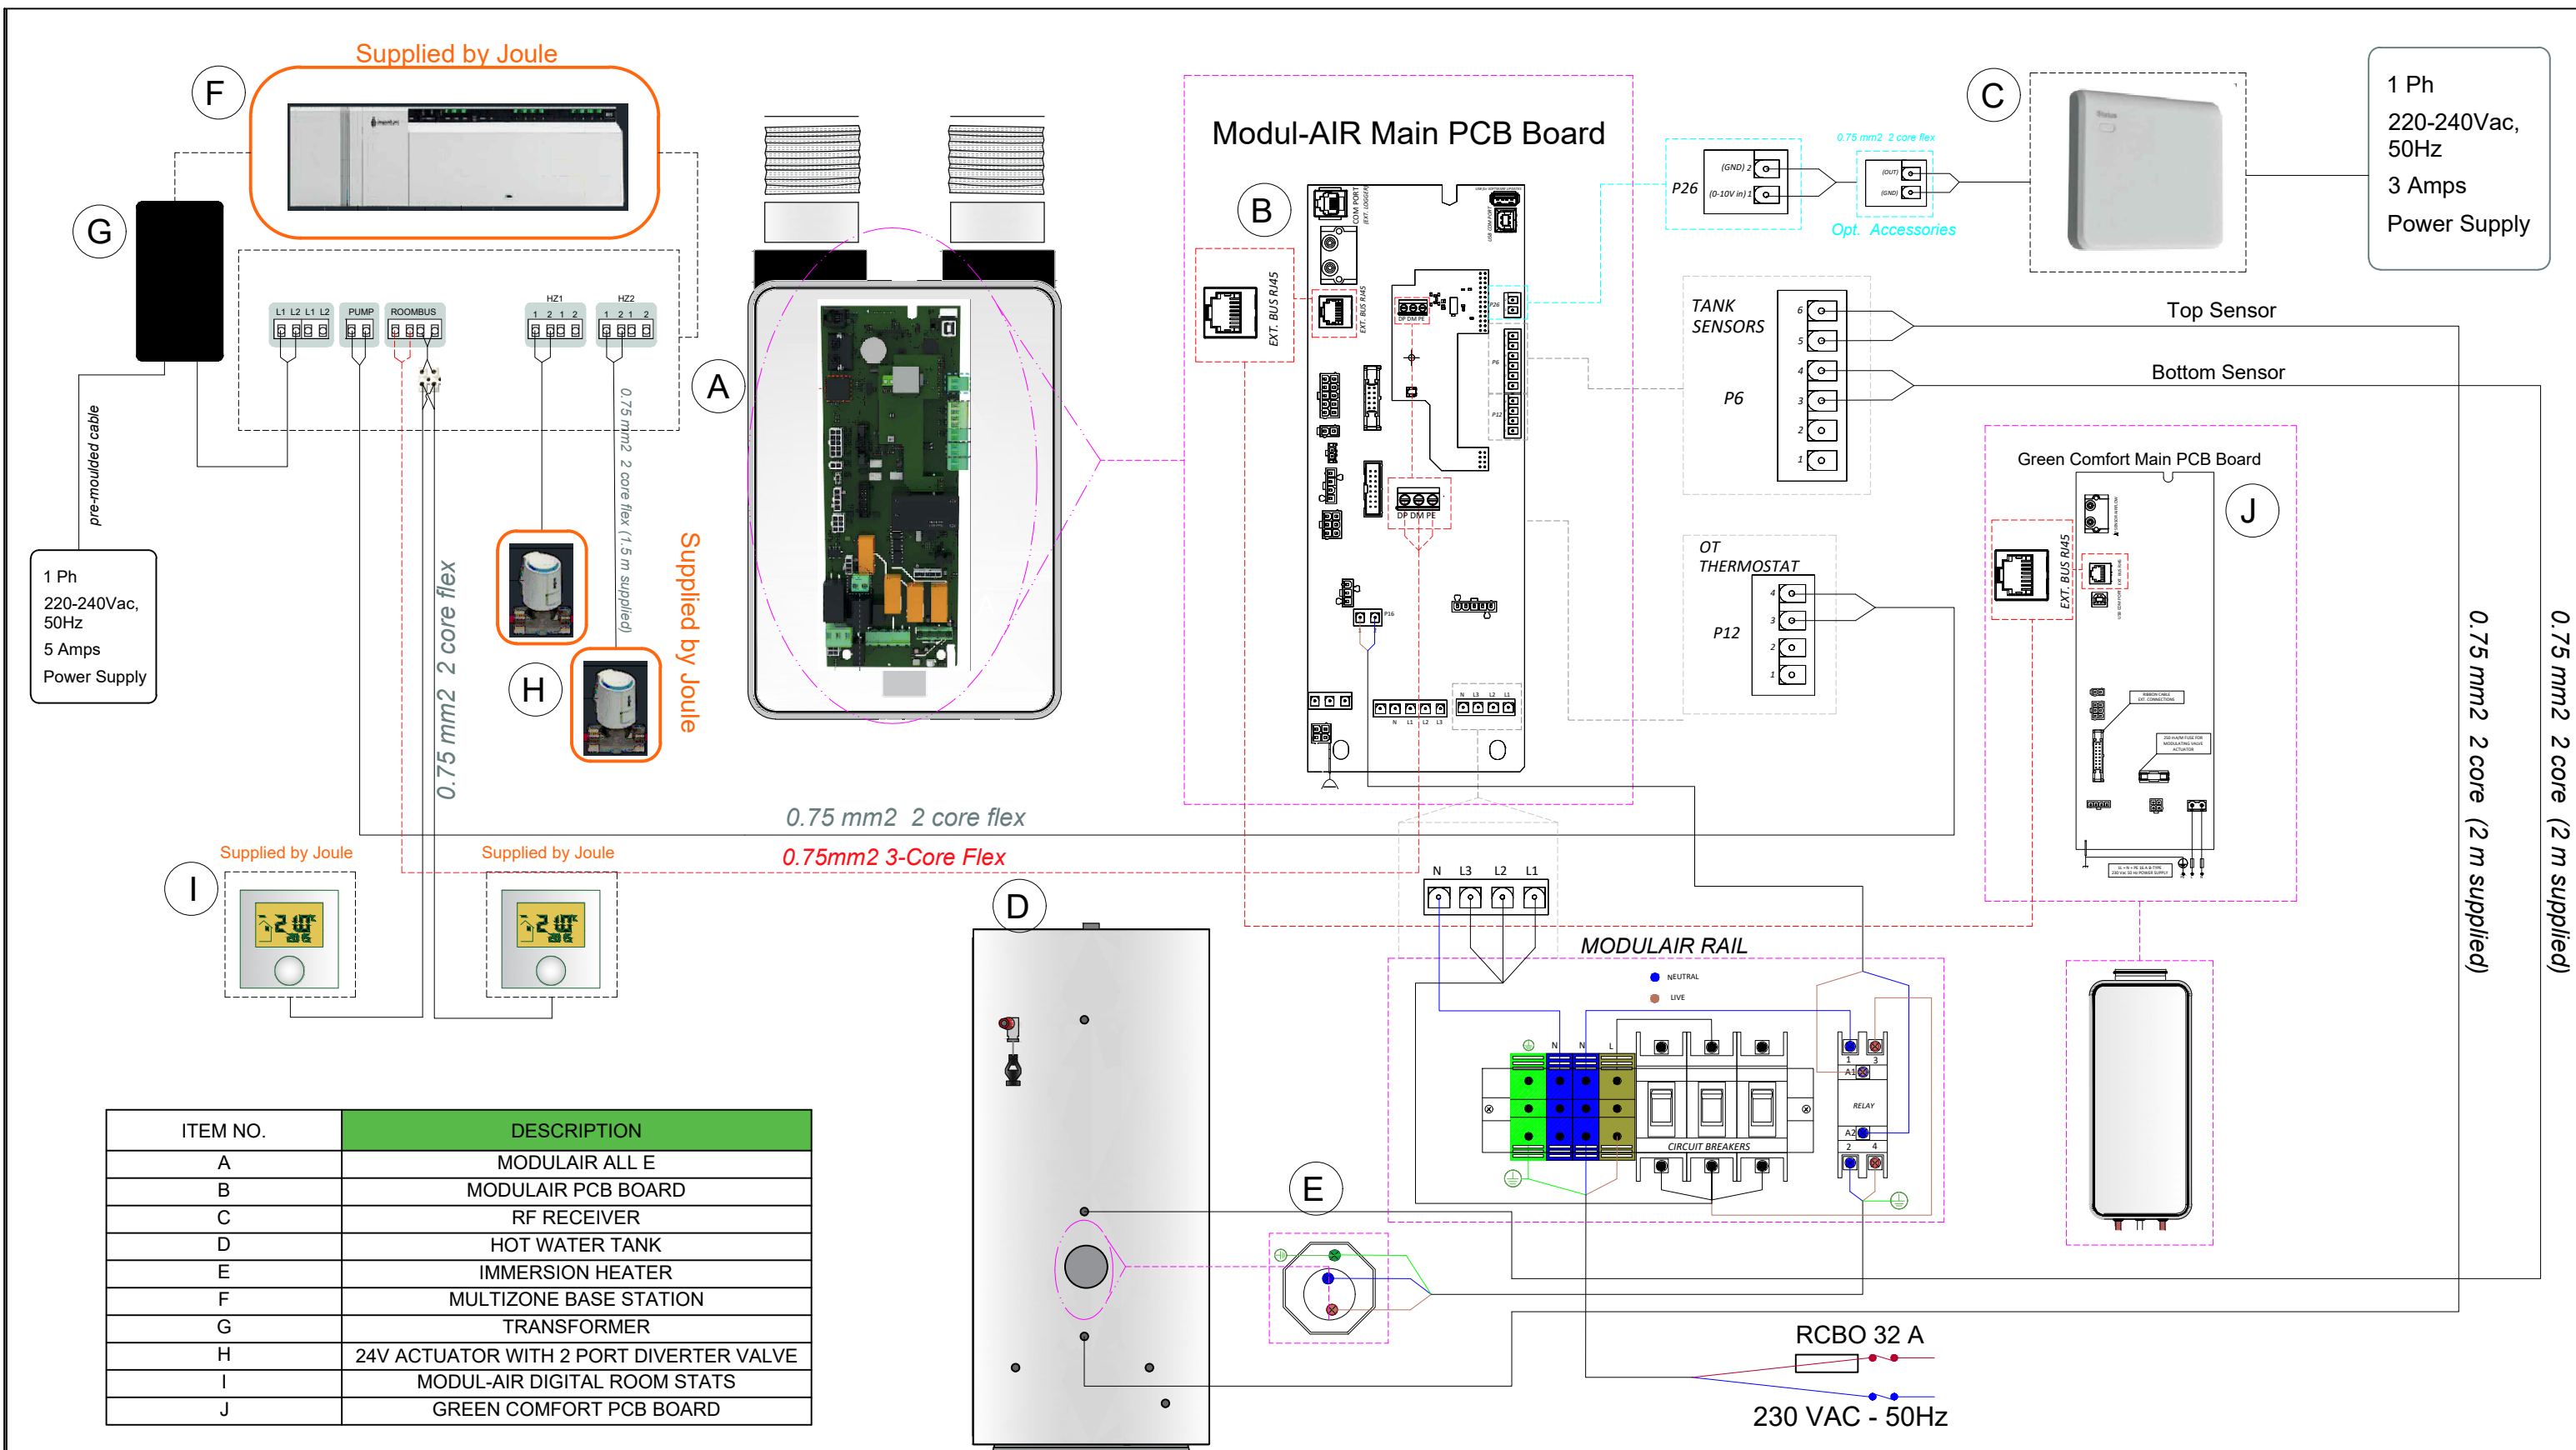

Modulair All-E & GC with 2 Zone Radiators Electrical Schematic

Front View of Unit & Cylinder

CLIENT	PROJECT	DRAWING TYPE	MODULAIR ALL E & GC 2 ZONE RADIATOR ELECTRICAL DETAILS			
	ELECTRICAL SCHEMATIC	DRAWING TITLE				
ON BEHALF OF	HOUSE TYPE	DRAWING NUMBER	0000	SCALE		1:50 @ A3
	EXAMPLE	DRAWING DATE		REVISION		0