


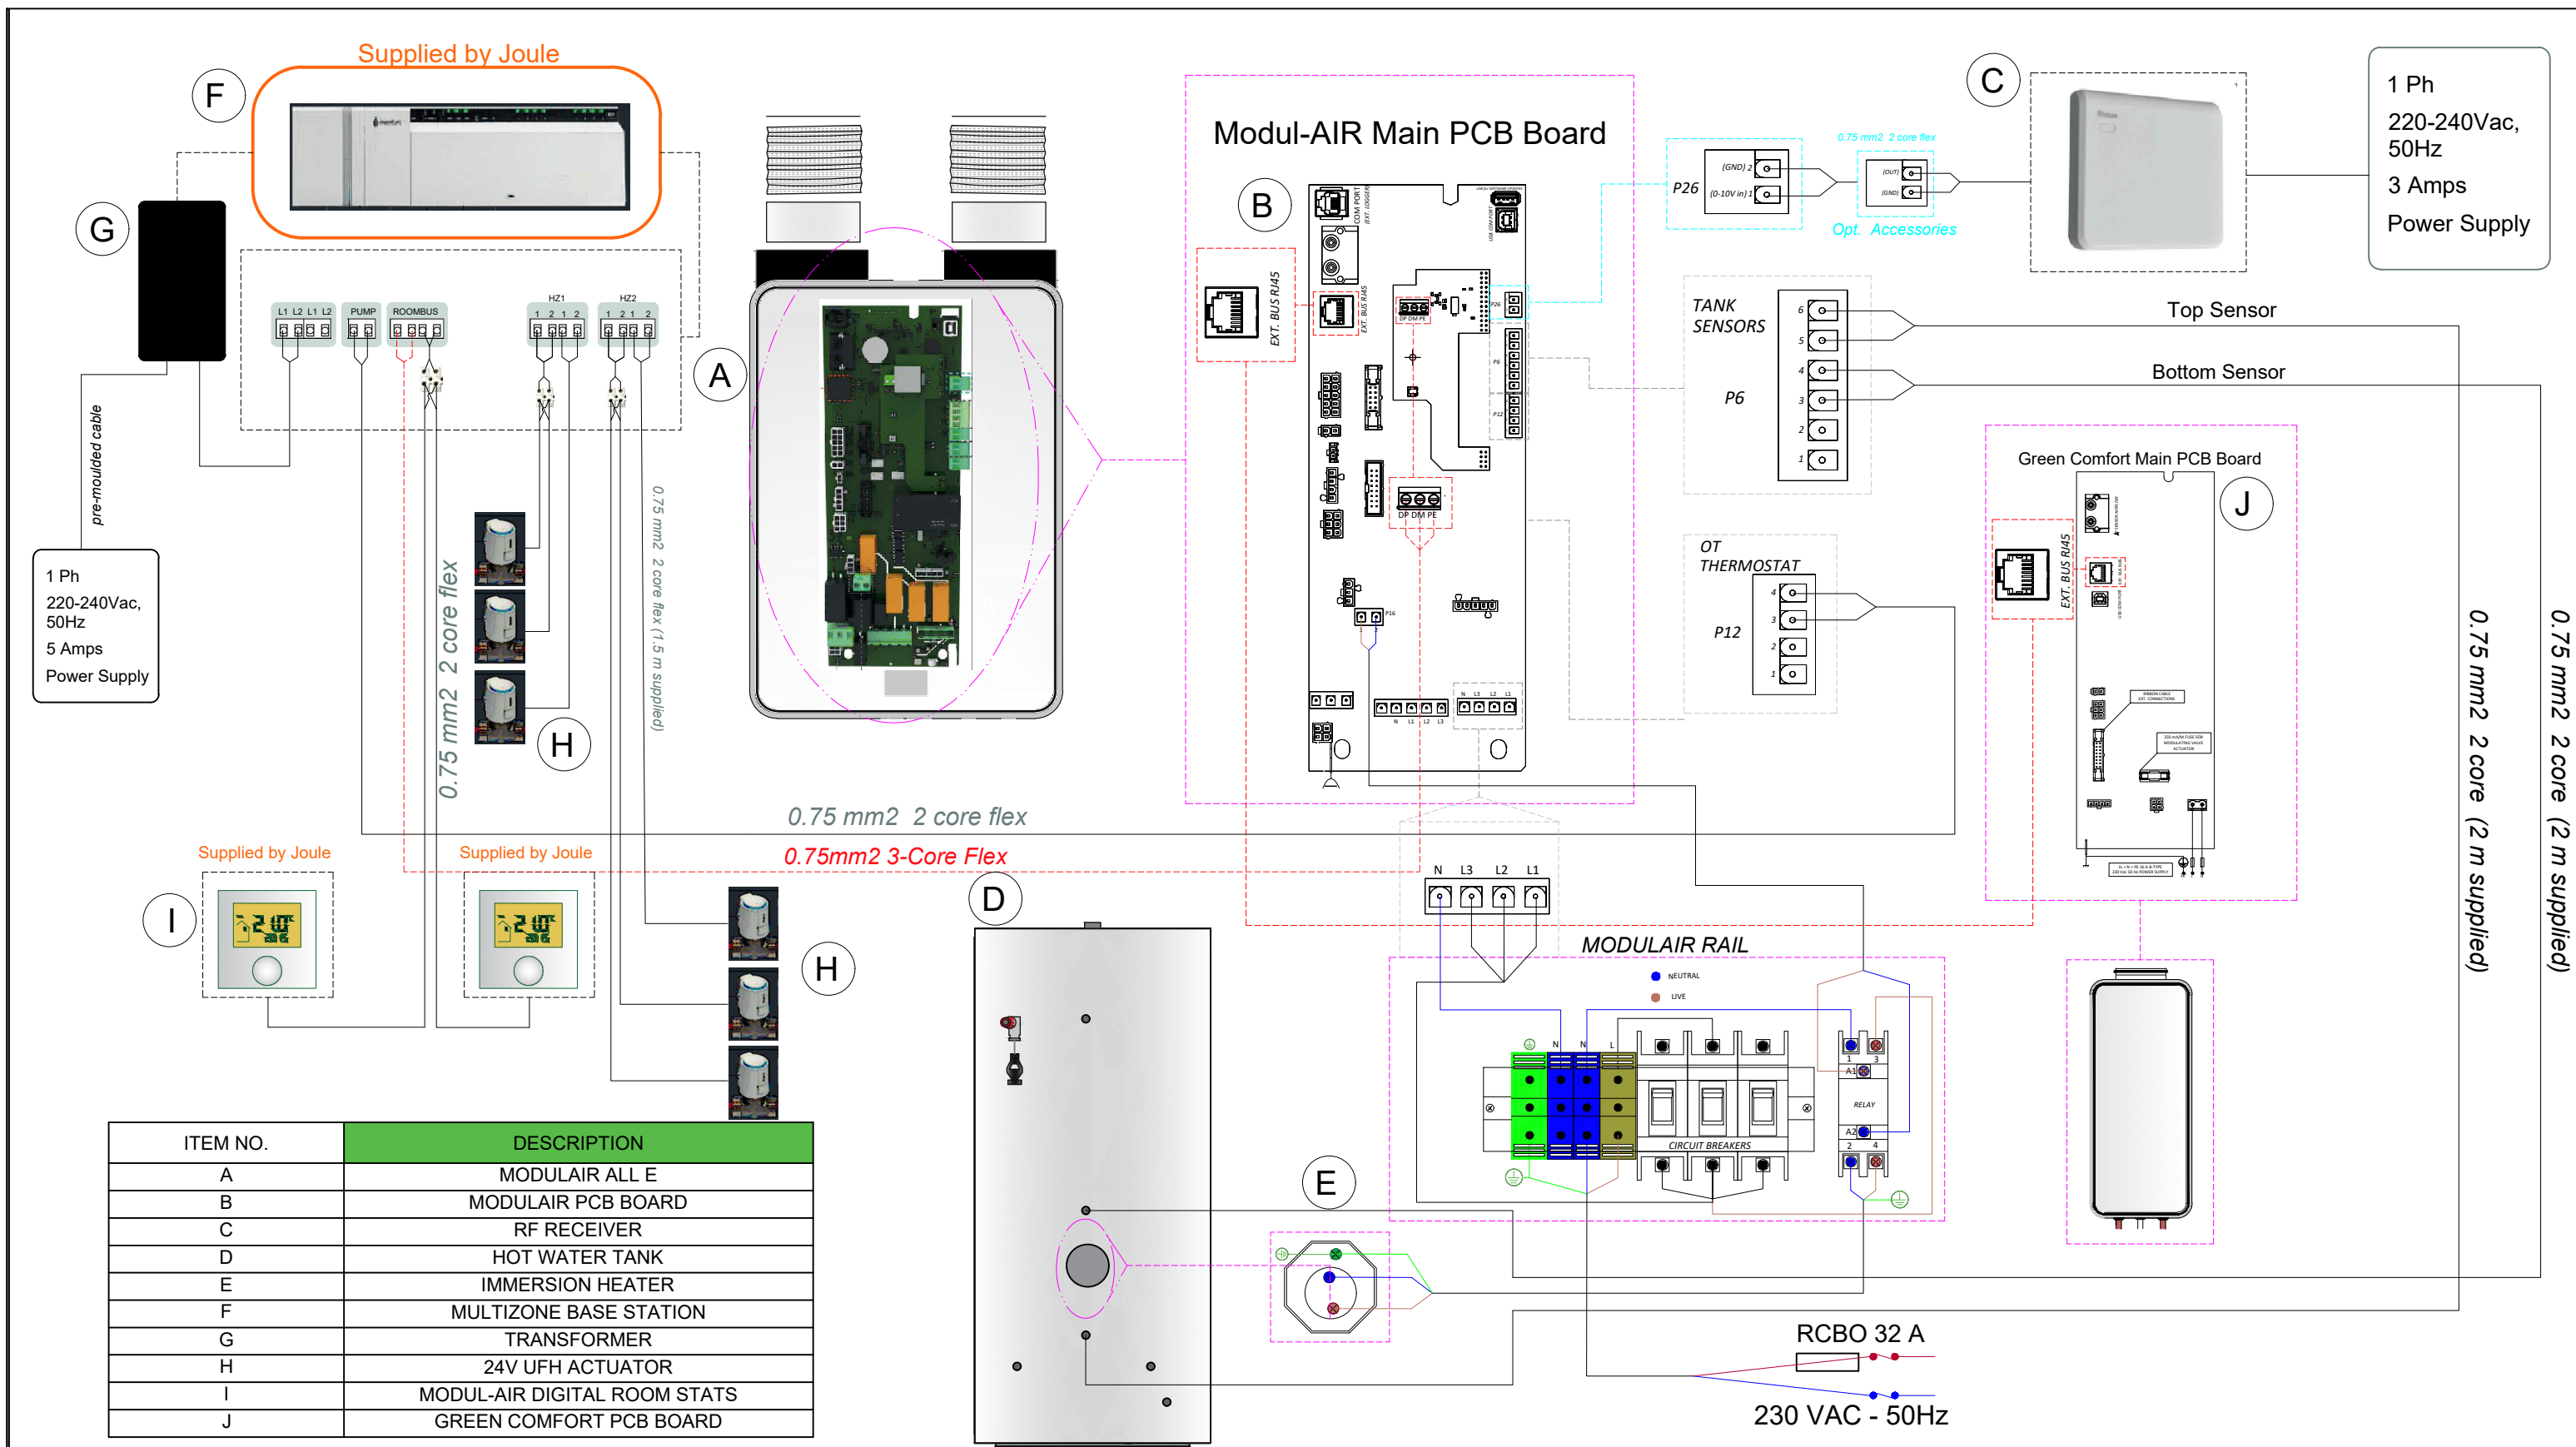

Modulair All-E & GC with 2 Zone UFH Electrical Schematic

Front View of Unit & Cylinder

CLIENT	PROJECT ELECTRICAL SCHEMATIC	DRAWING TYPE MODULAIR ALL E & GC 2 ZONE UFH ELECTRICAL DETAILS	
ON BEHALF OF JOULE HEATING SOLUTIONS	HOUSE TYPE EXAMPLE	DRAWING NUMBER 0000	SCALE 1:50 @ A3 REVISION 0

