


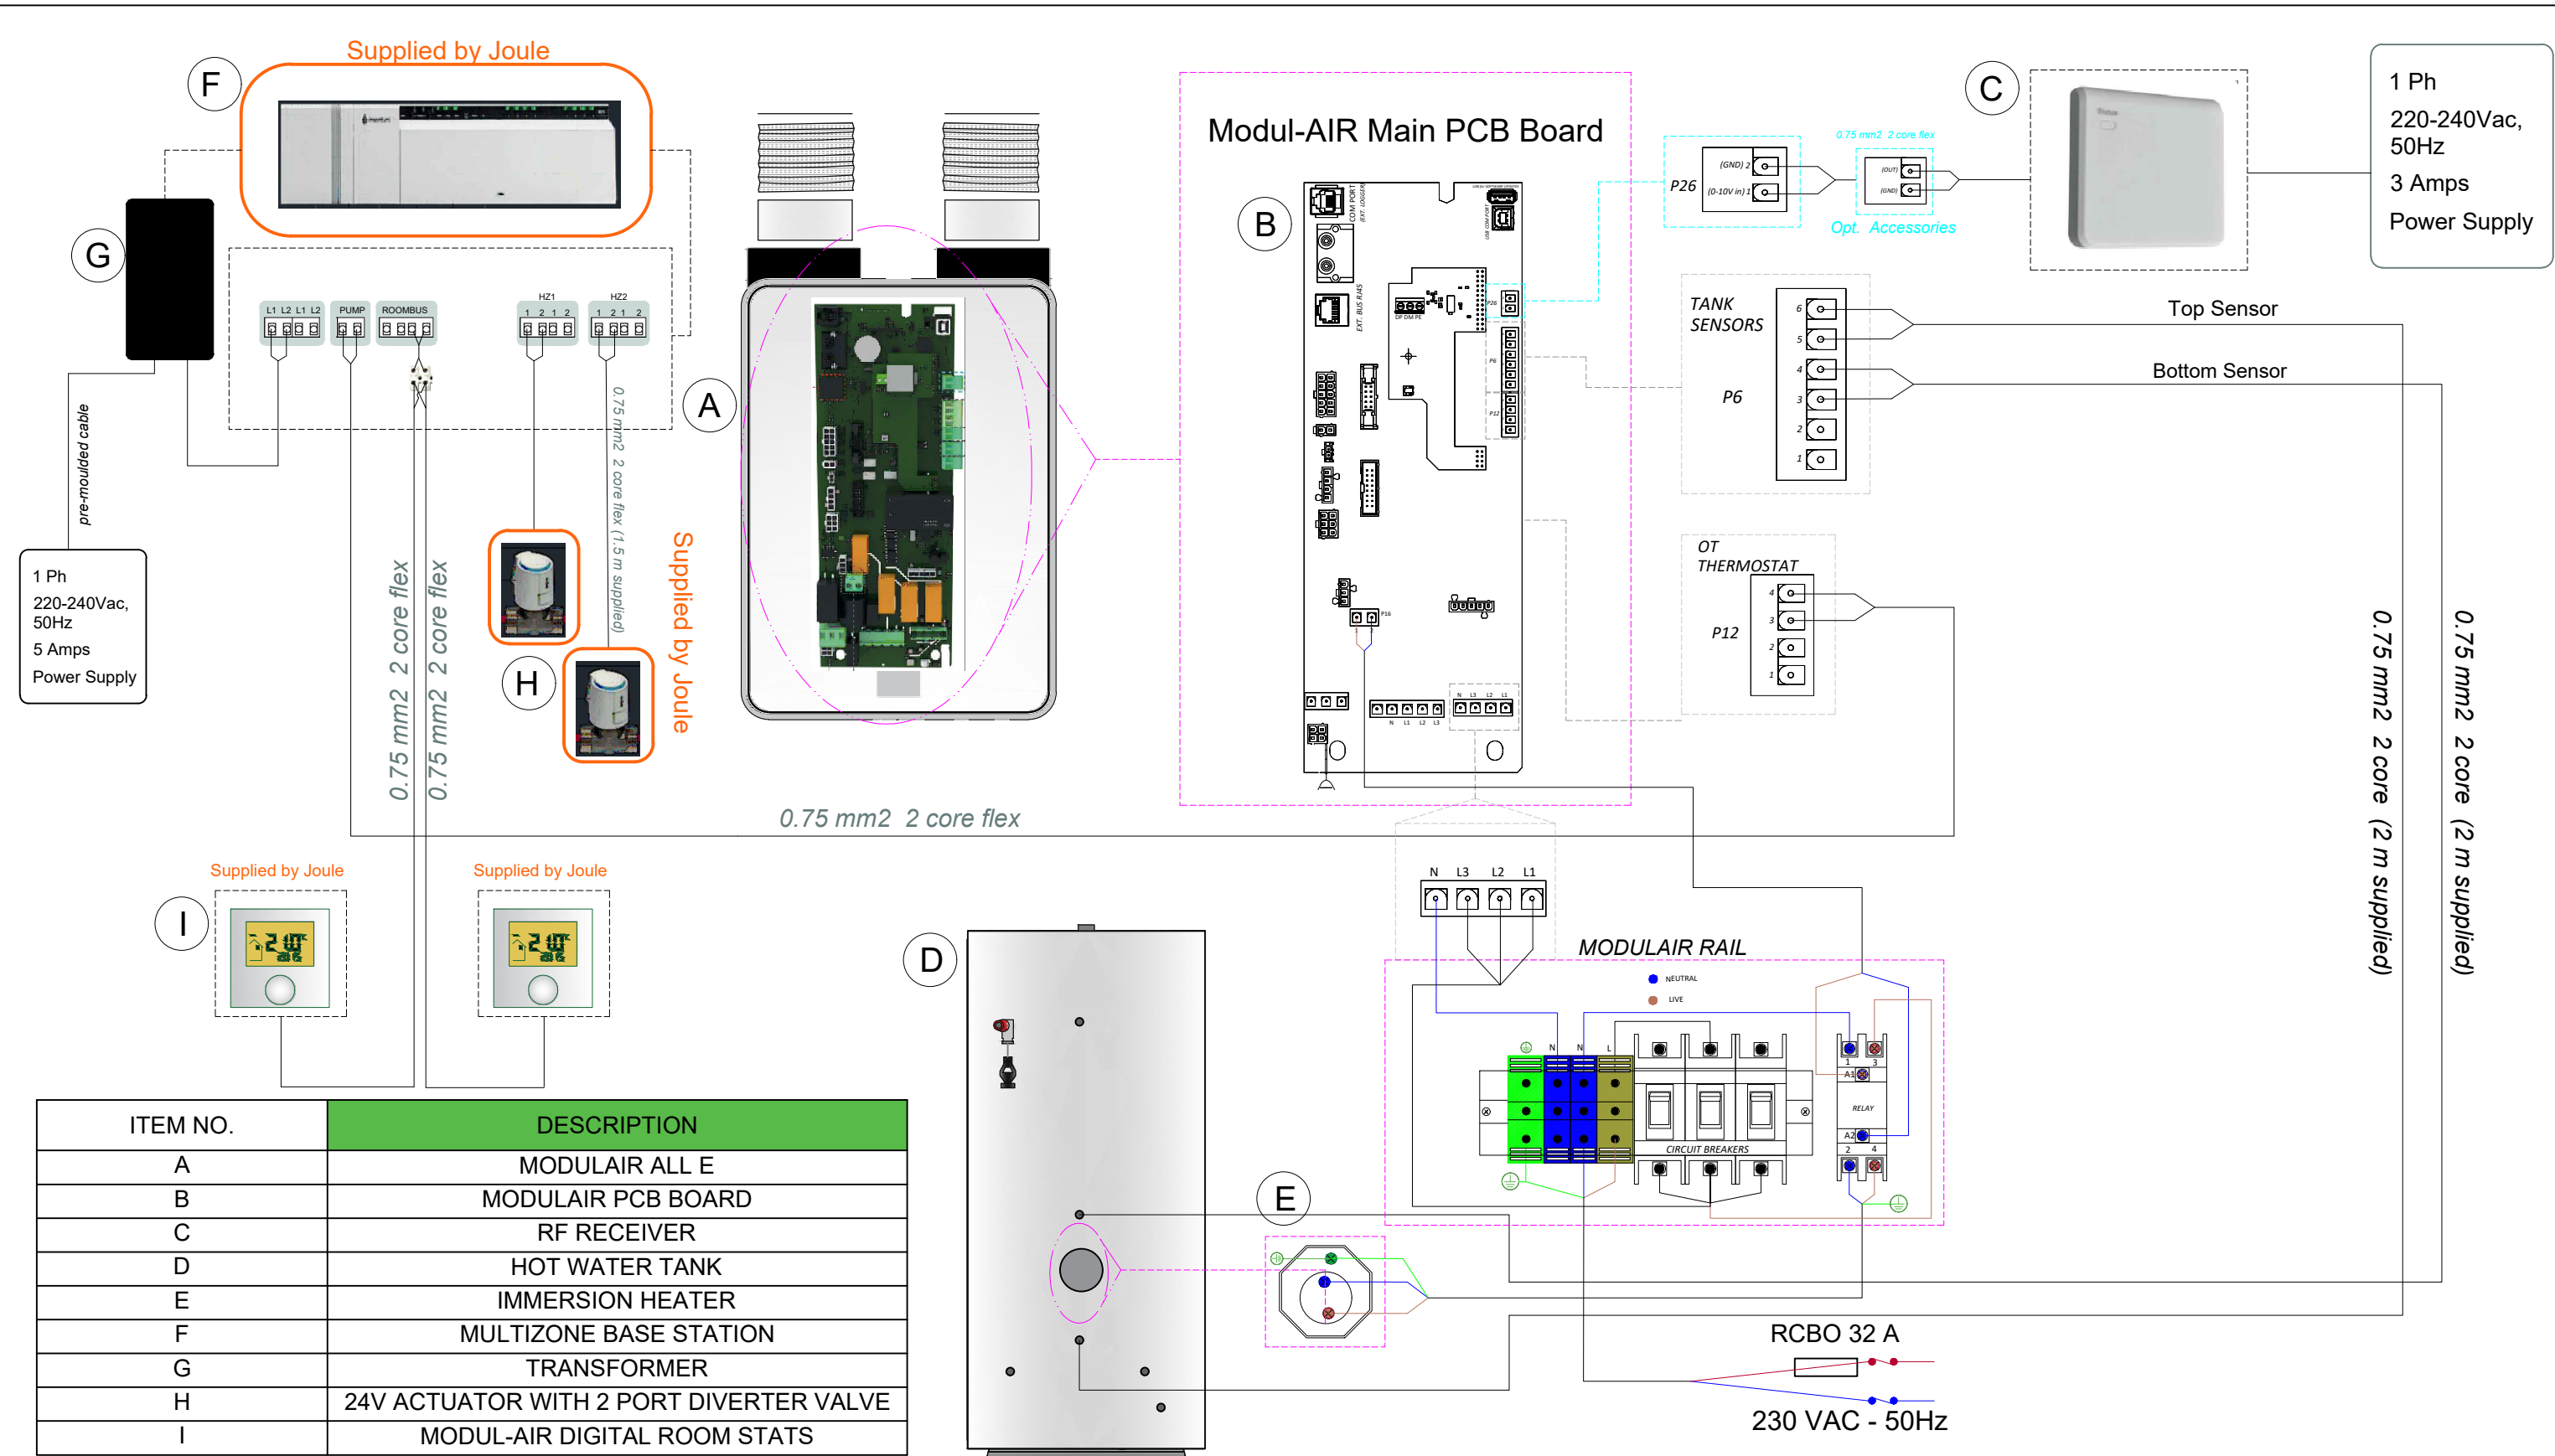

Modulair All-E with 2 Zone Radiators Electrical Schematic

Front View of Unit & Cylinder

CLIENT	PROJECT	DRAWING TYPE	MODULAIR ALL E 2 ZONE RADIATORS ELECTRICAL DETAILS	
	ELECTRICAL SCHEMATIC	DRAWING TITLE		
ON BEHALF OF	HOUSE TYPE	DRAWING NUMBER	0000	SCALE 1:50 @ A3
JOULE HEATING SOLUTIONS	EXAMPLE	DRAWING DATE		REVISION 0