


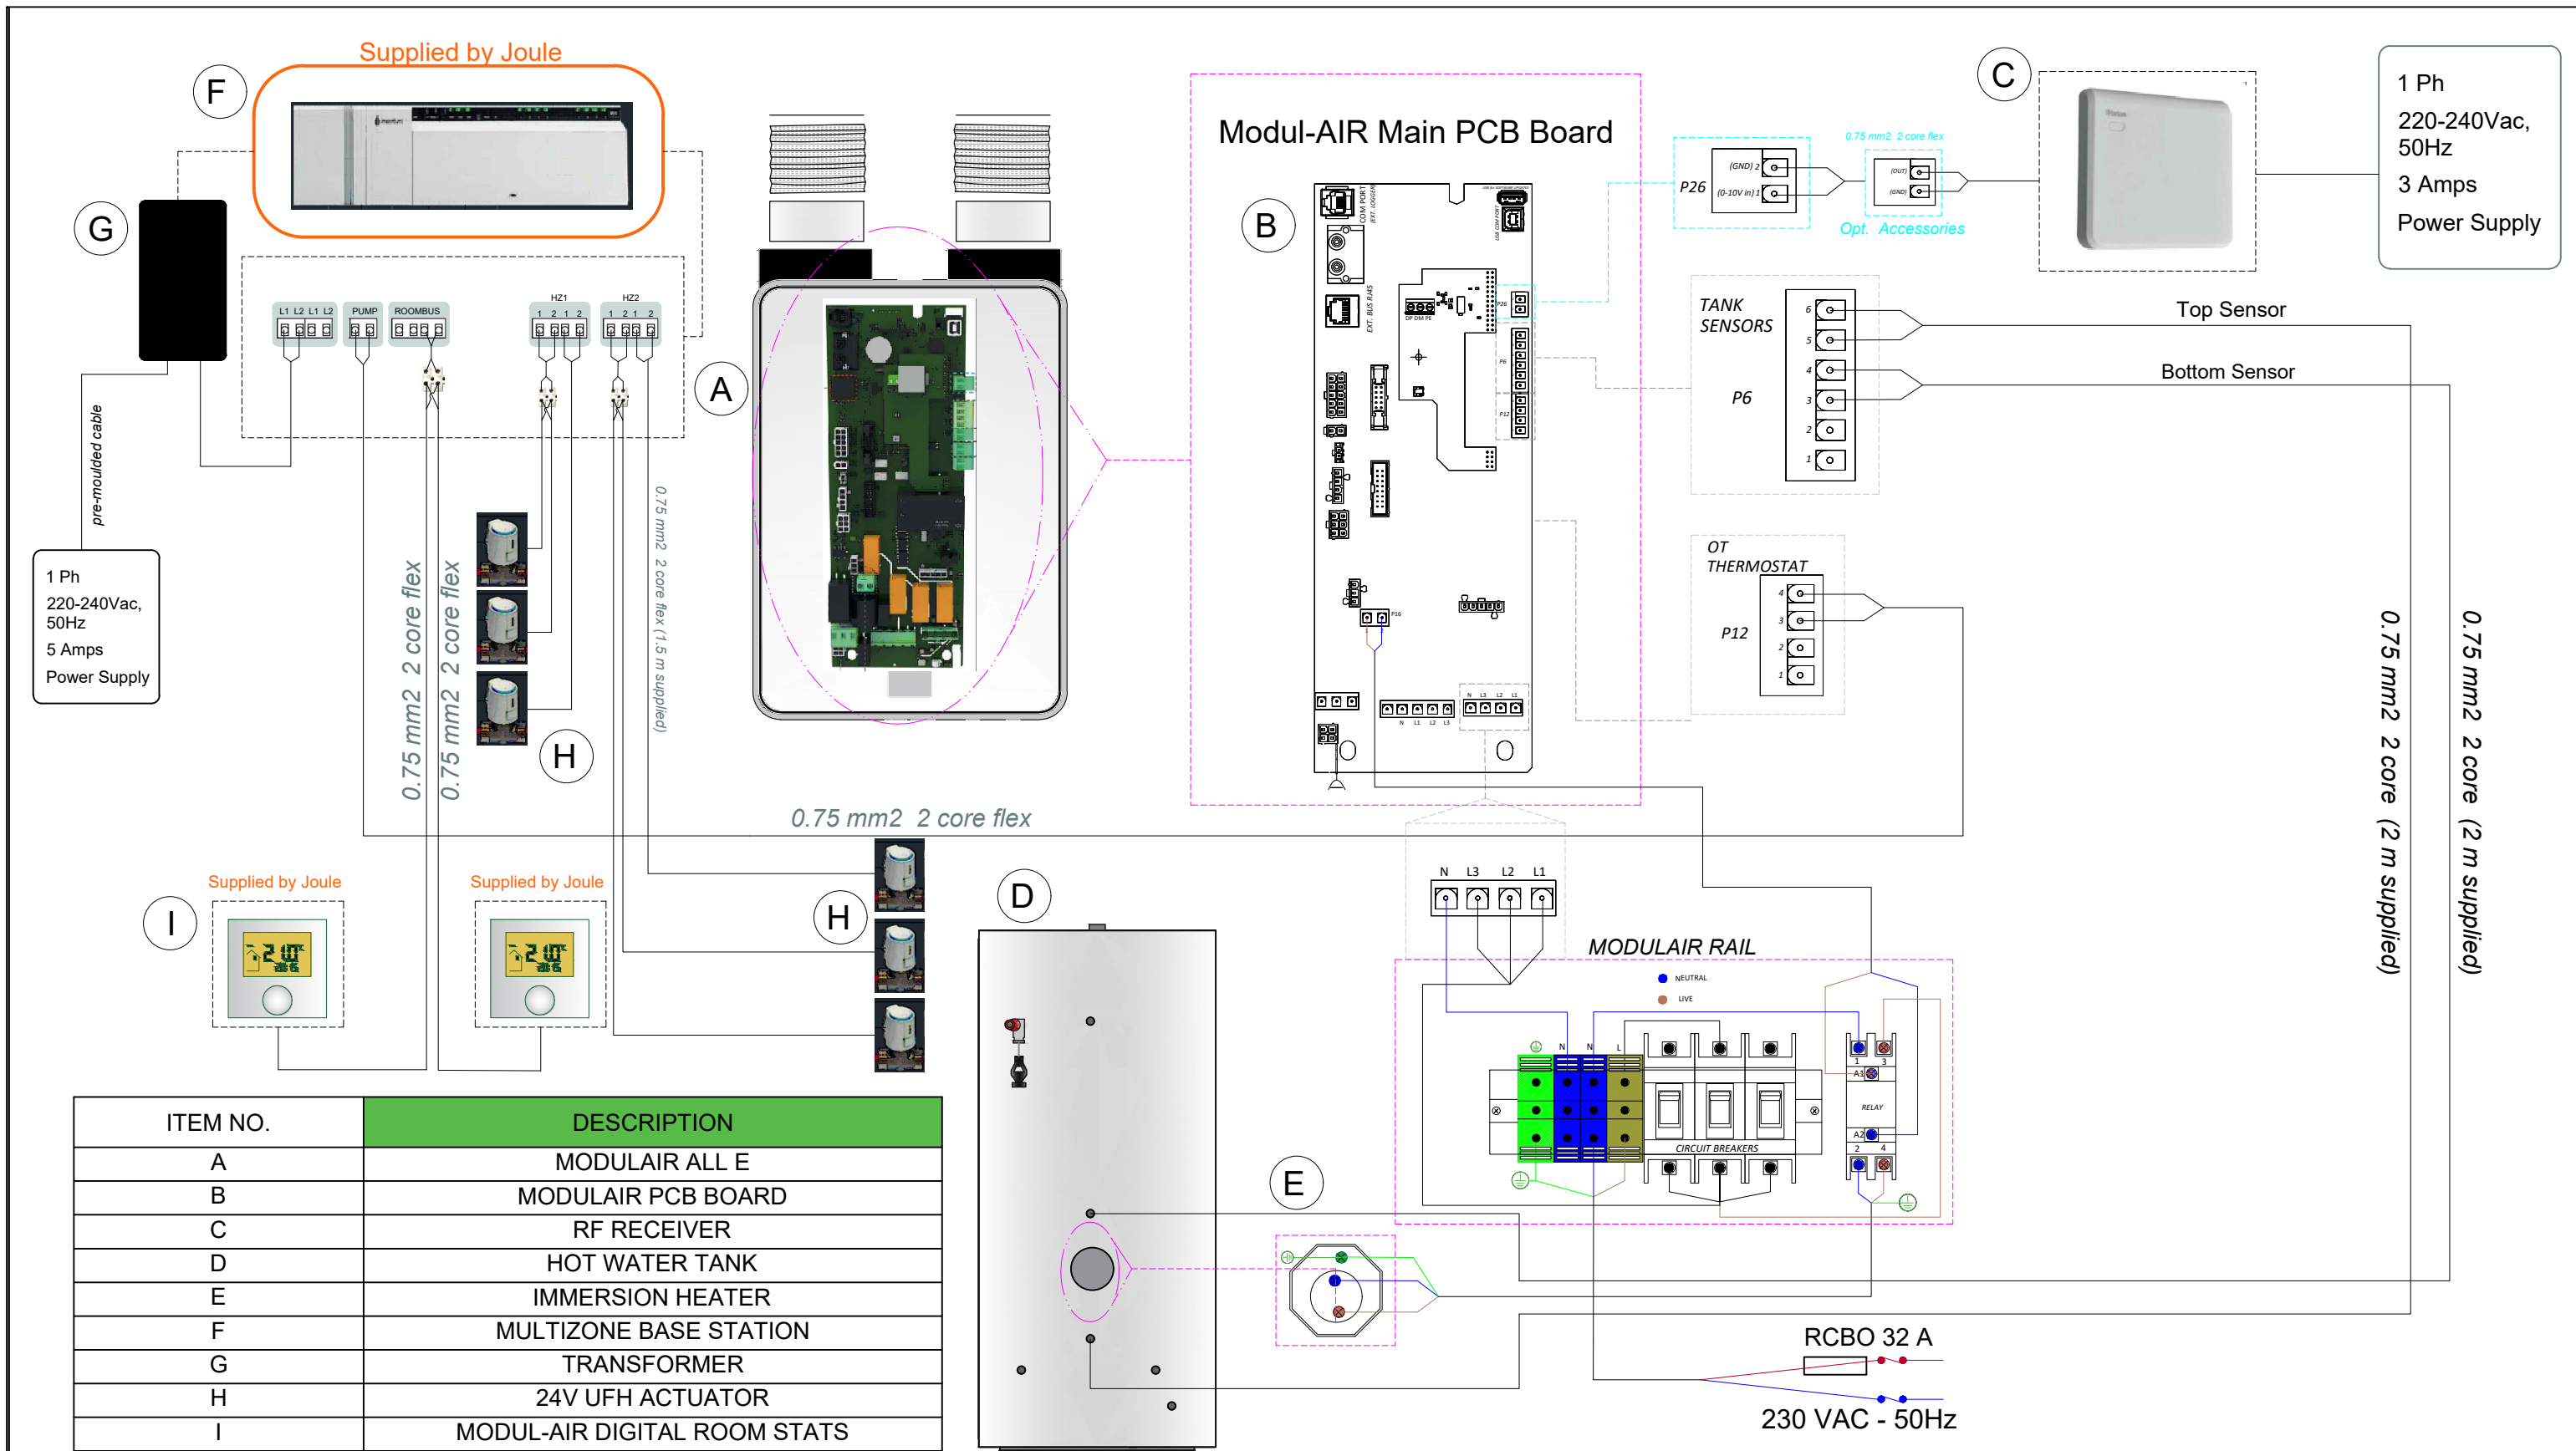

ITEM NO.	DESCRIPTION
A	MODULAIR ALL E
B	MODULAIR PCB BOARD
C	RF RECEIVER
D	HOT WATER TANK
E	IMMERSION HEATER
F	MULTIZONE BASE STATION
G	TRANSFORMER
H	24V UFH ACTUATOR
I	MODUL-AIR DIGITAL ROOM STATS

Modulair All-E with 2 Zone UFH Electrical Schematic

Front View of Unit & Cylinder

CLIENT	PROJECT	DRAWING TYPE	MODULAIR ALL E 2 ZONE UFH ELECTRICAL DETAILS	
	ELECTRICAL SCHEMATIC	DRAWING TITLE		
ON BEHALF OF	HOUSE TYPE	DRAWING NUMBER	0000	SCALE 1:50 @ A3
JOULE HEATING SOLUTIONS	EXAMPLE	DRAWING DATE		REVISION 0

